


| FHWA REGION | STATE | FED. AID PROJ. NO. | SHEET NO. |
|-------------|-------|--------------------|-----------|
| 8 | N.D. | RRS-1-006(005)066 | 105 |

① Revised 1-18-91

Ⓐ The contractor shall locate the existing conductor and salvage sufficient wire to make the connection to provide continuity

Remove Wood Pole Light Std.
 Sta. 739+73-29' Lt. 1 Ea.
 Sta. 741+21.5-32.6' Lt. 1 Ea.

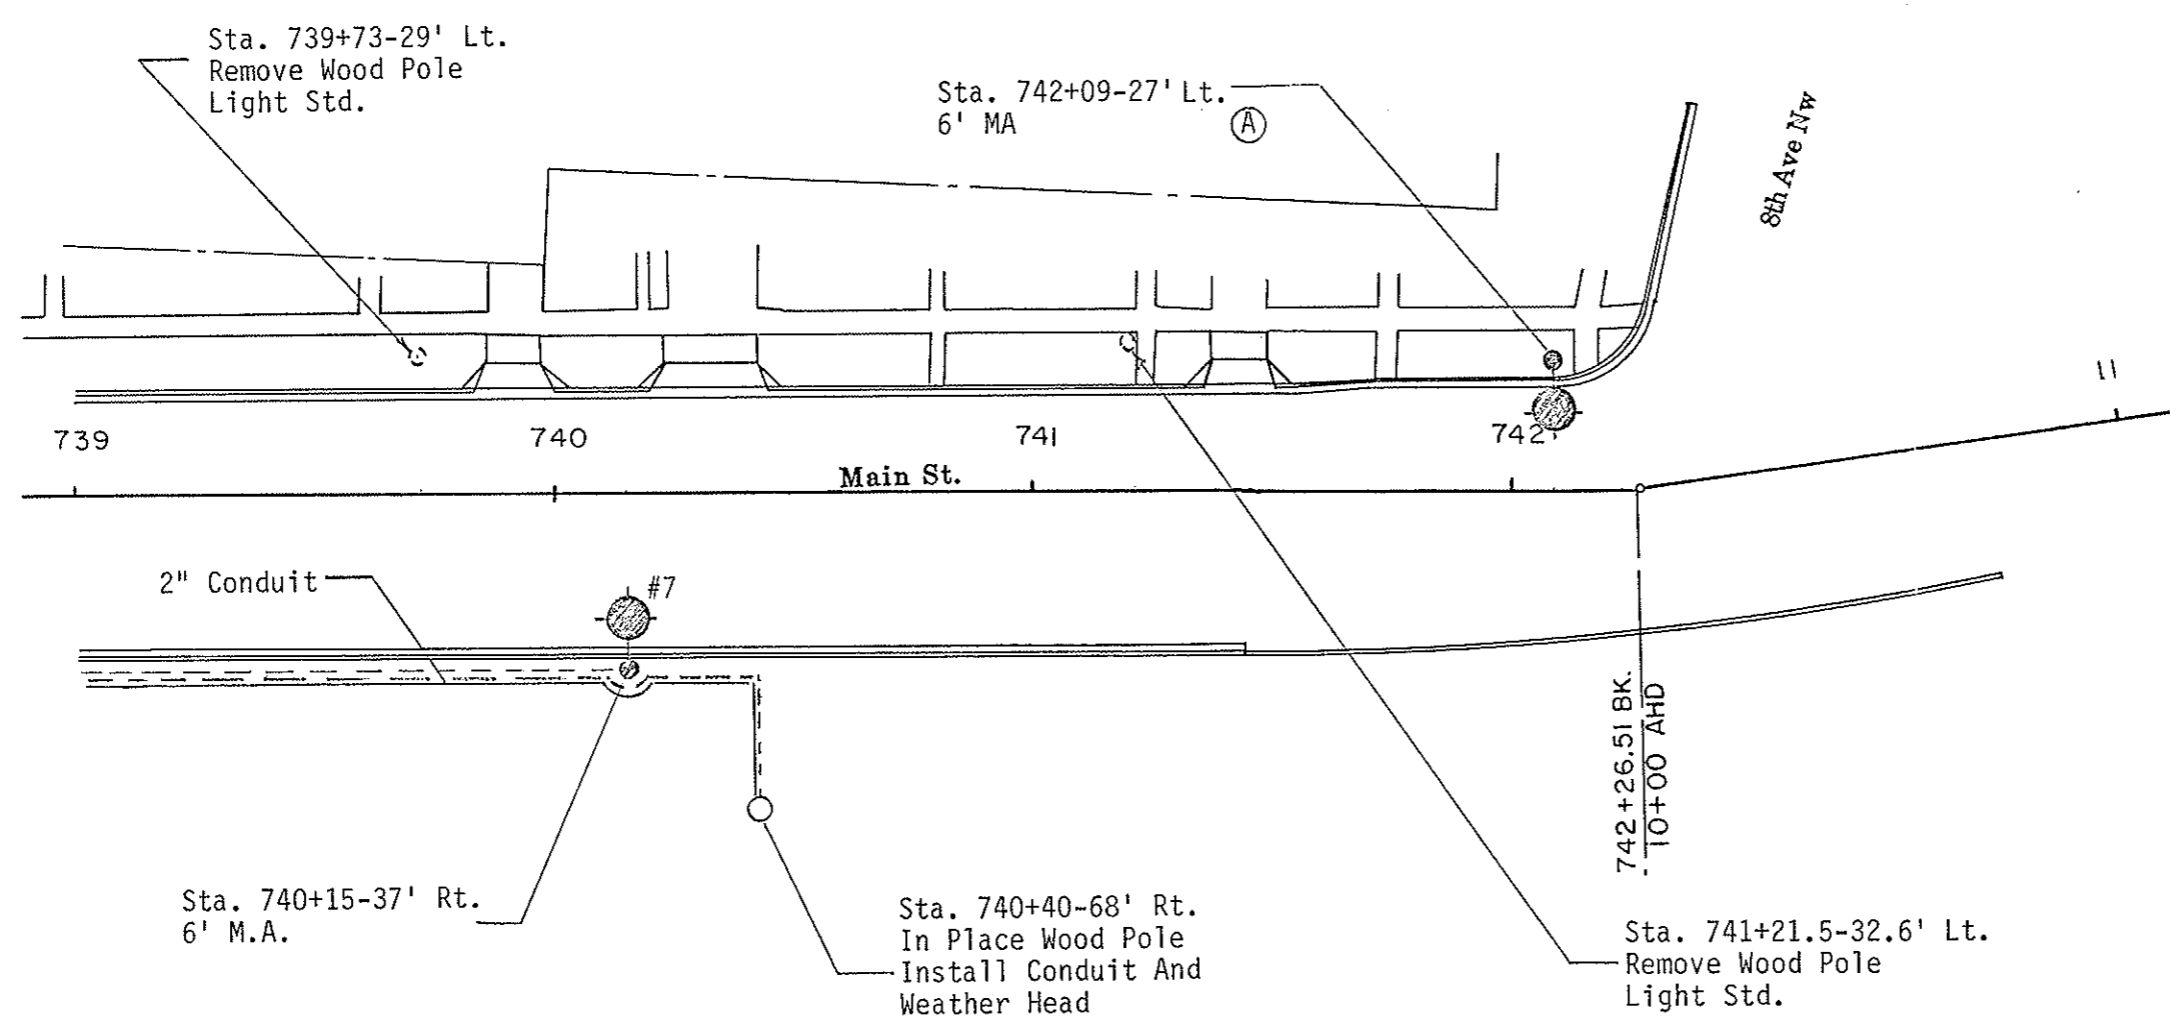

①

TRAFFIC CONTROL SYSTEM
 Lighting Layout
 739+00 to 11+00
 Main Av.
 10th Ave sw (ND Hwy 6)
 Mandan N.D.