



PLAN VIEW  
SCALE: 1/4" = 1'

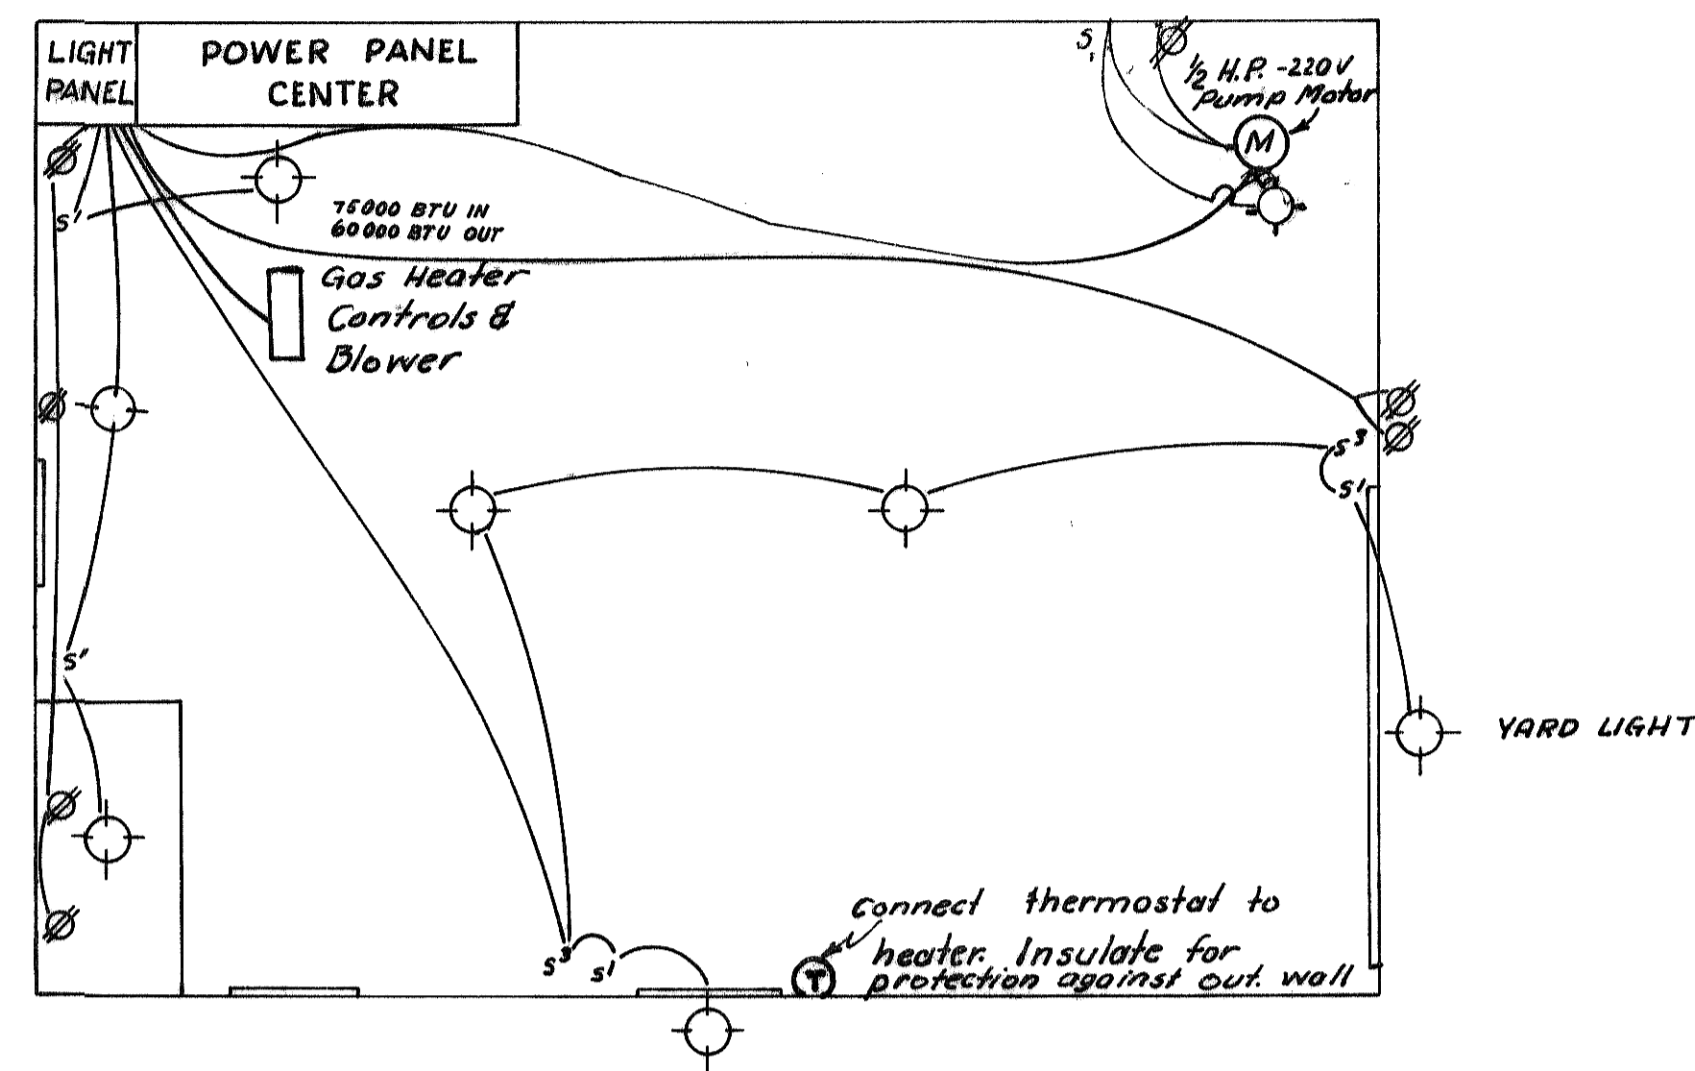


BLDG LIGHTING LAYOUT  
SCALE: 1/4" = 1'

- LIGHT FIXTURE
- ⊗ CONVENIENCE OUTLET
- ⊙ SINGLE POLE SWITCH
- ⊕ DOUBLE POLE SWITCH (2-WAY)
- ⊖ THERMOSTAT

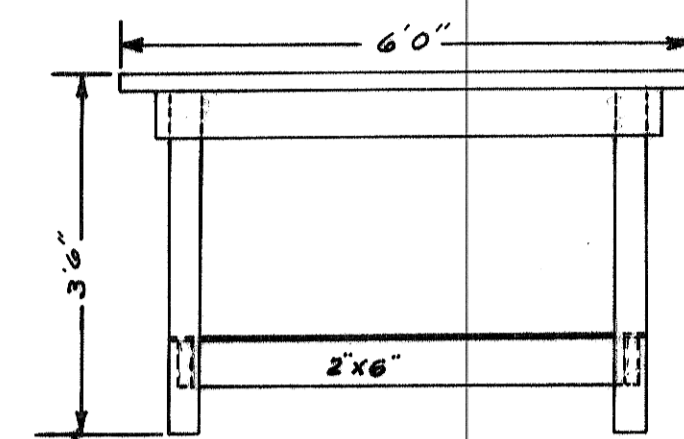


SIDE VIEW


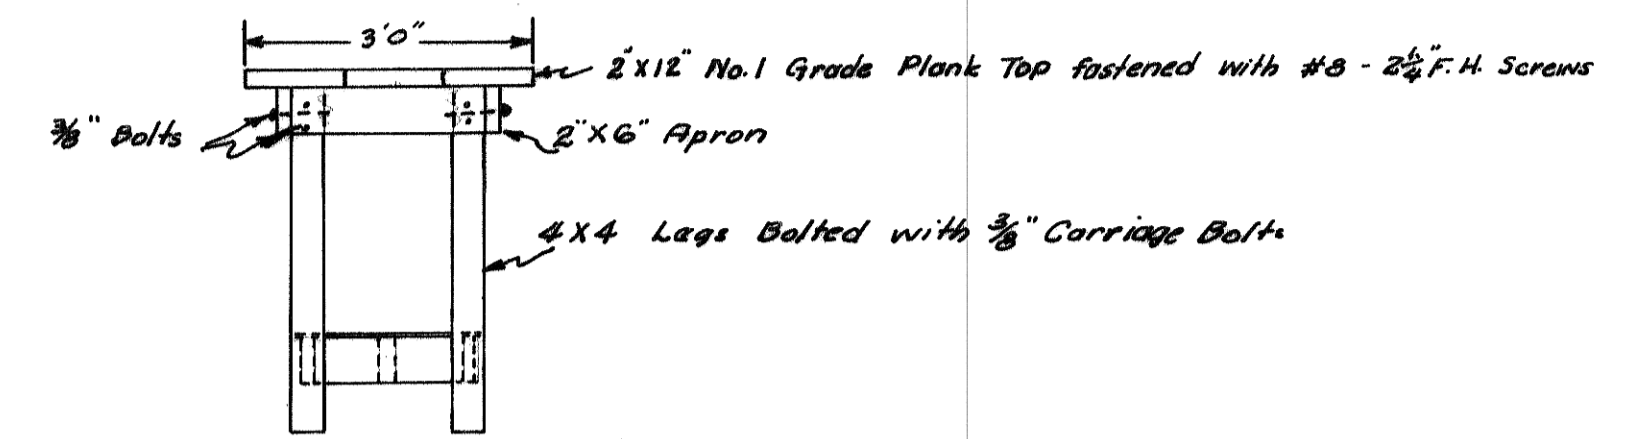


END VIEW


WORK BENCH  
SCALE: 1/2" = 1'

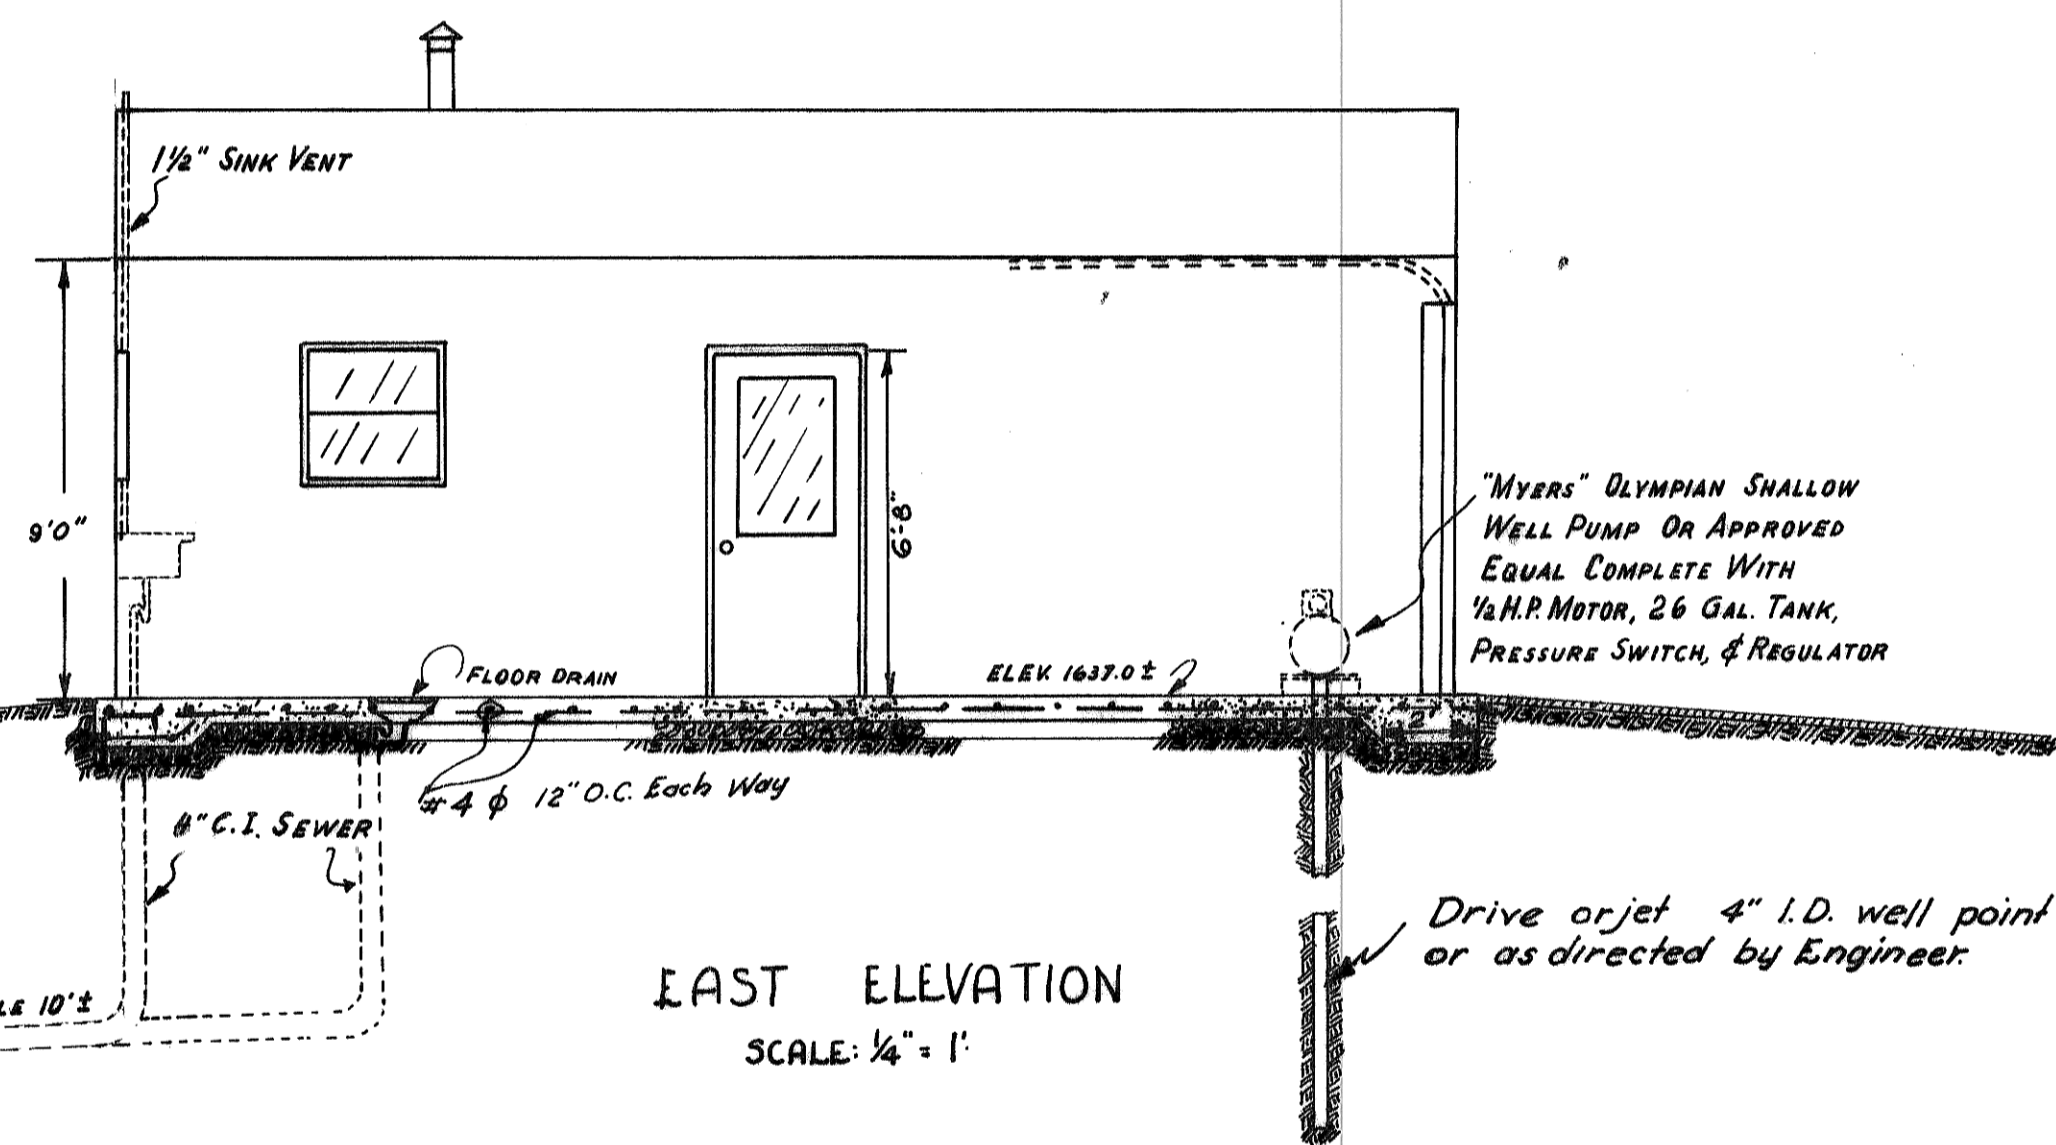


EAST ELEVATION  
SCALE: 1/4" = 1'

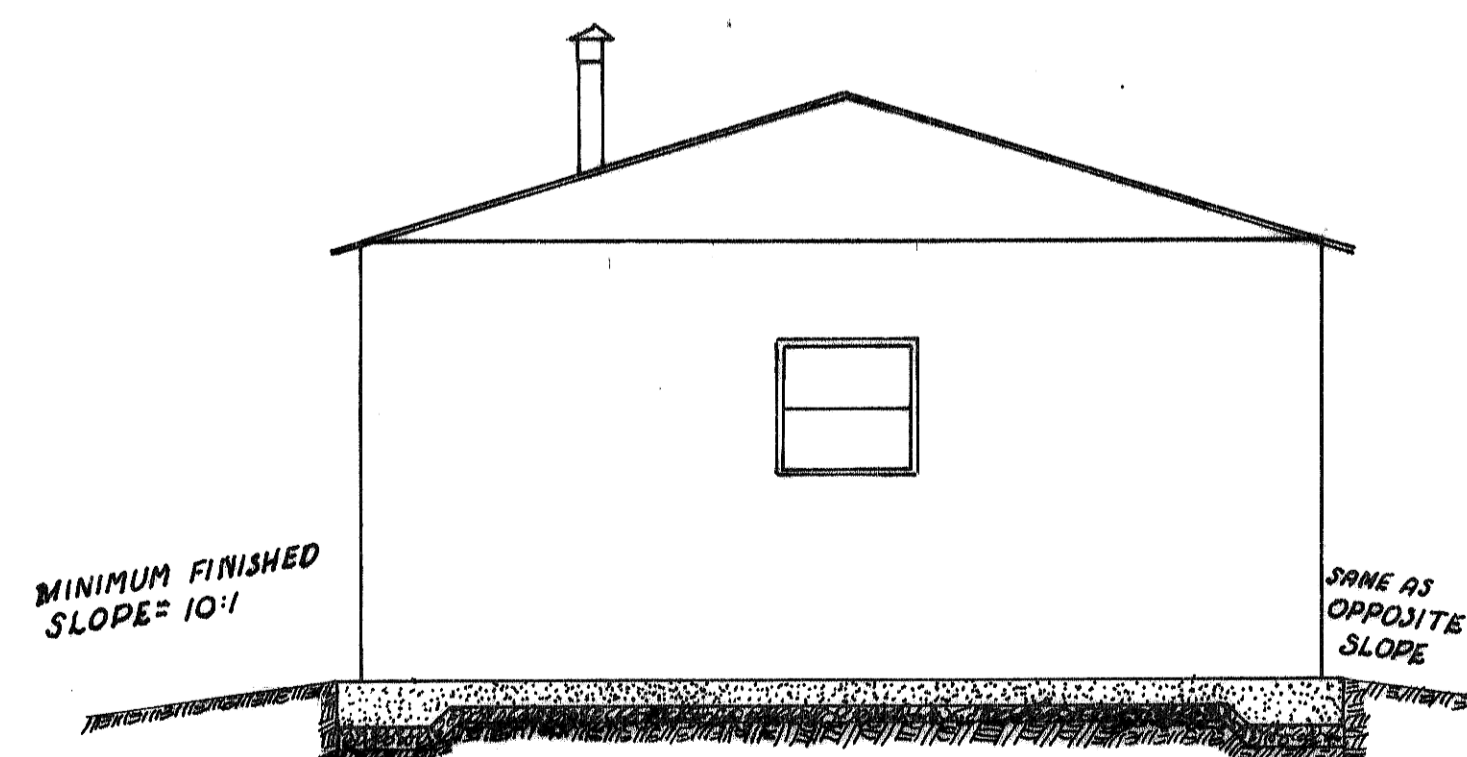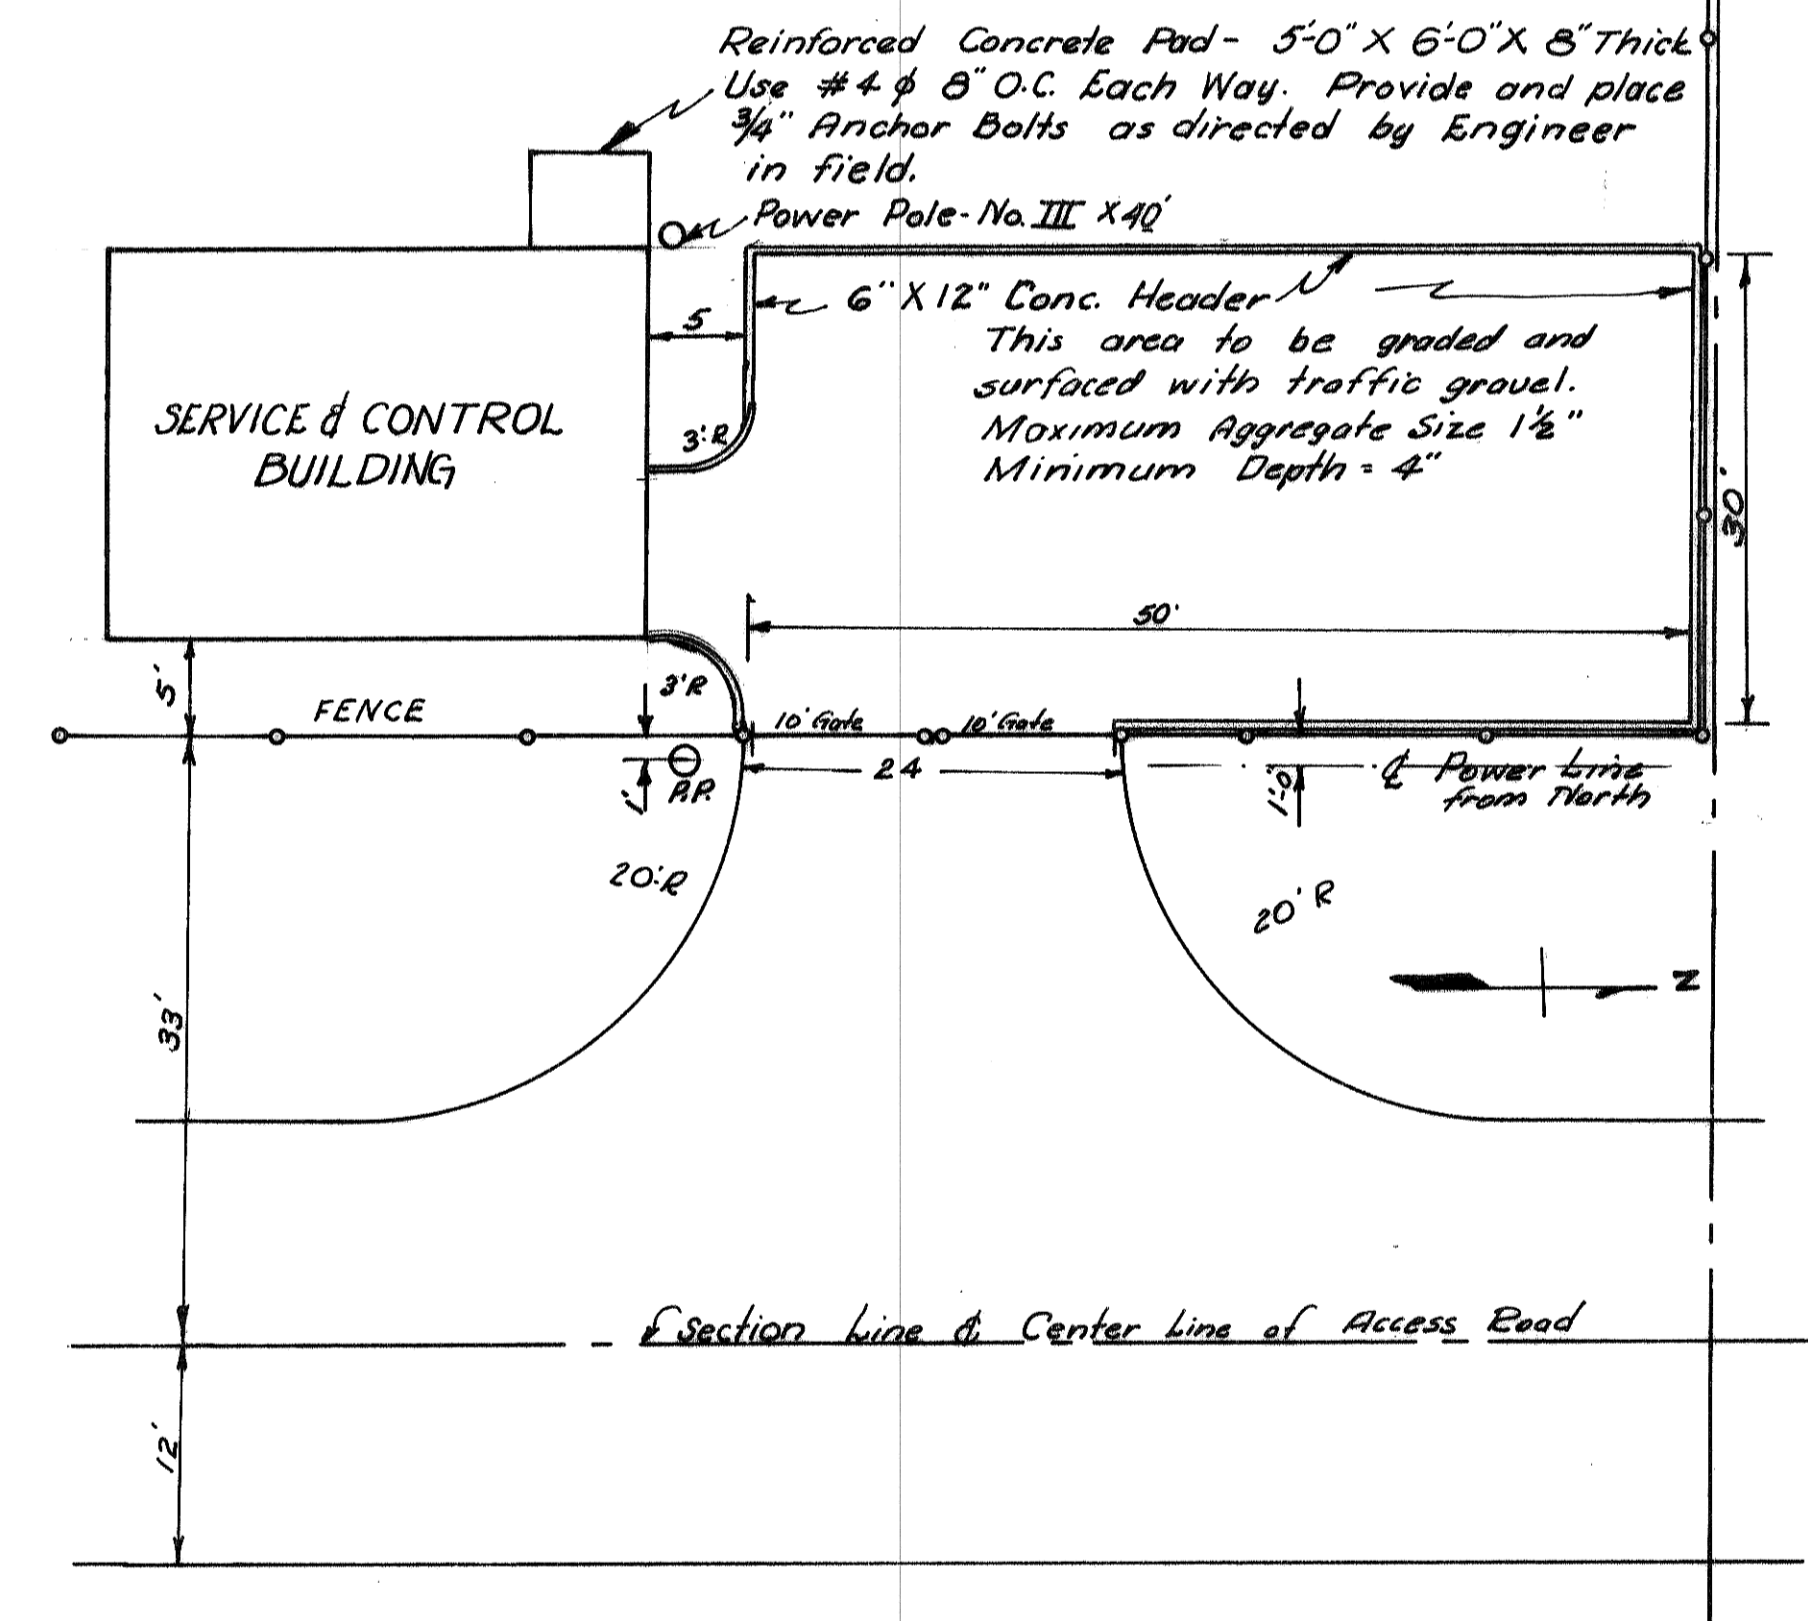

SOUTH ELEVATION  
SCALE: 1/4" = 1'

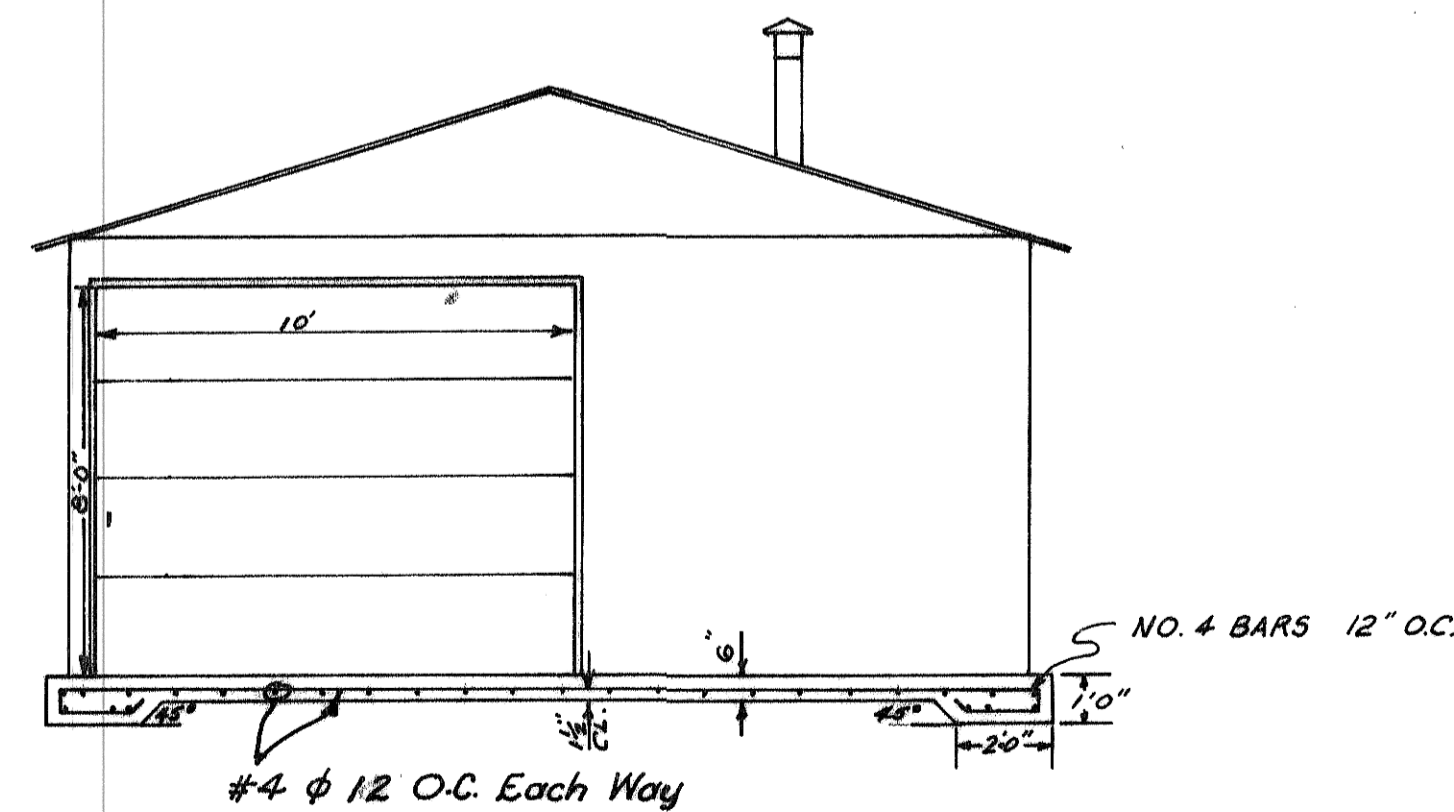

NORTH ELEVATION  
SCALE: 1/4" = 1'

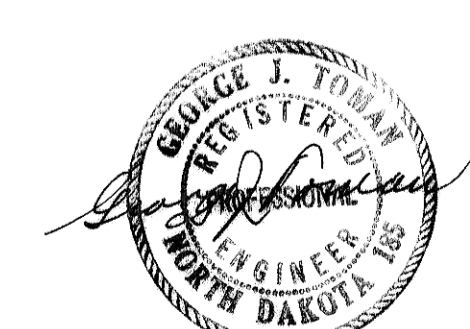

Job: **SANITARY SEWER IMPROVEMENT DISTRICT NO. 14 CITY OF MANDAN, NORTH DAKOTA**

File No. \_\_\_\_\_ Date: \_\_\_\_\_ Revised: \_\_\_\_\_

**SHEET NO. 25 OF 27 SHEETS**  
Scale: As Shown

DRAWN BY: G.P. CHECKED BY: G.J.T.  
**SERVICE AND CONTROL BUILDING AT LAGOON SITE**

George J. Toman  
R. P. E. No. 185

Consulting Engineer  
Mandan, North Dakota