



FLOOR PLAN
SCALE: 1/4" = 1'

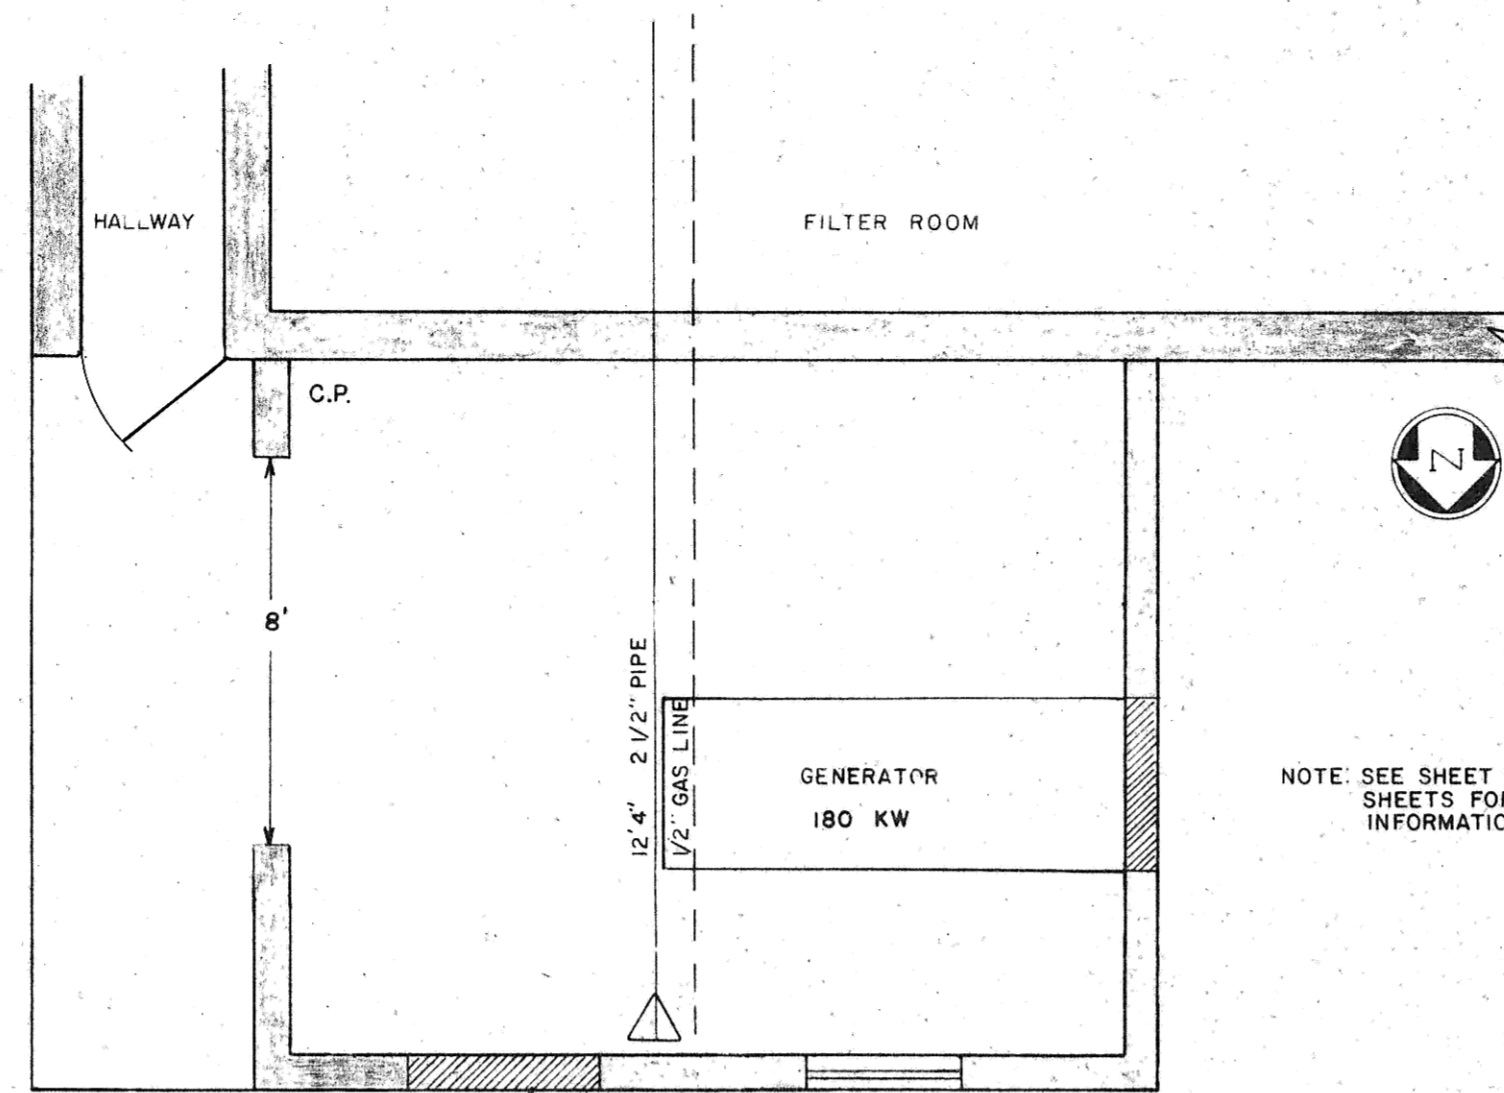


HEATING LAYOUT
SEE SHEET 5-B OF 23

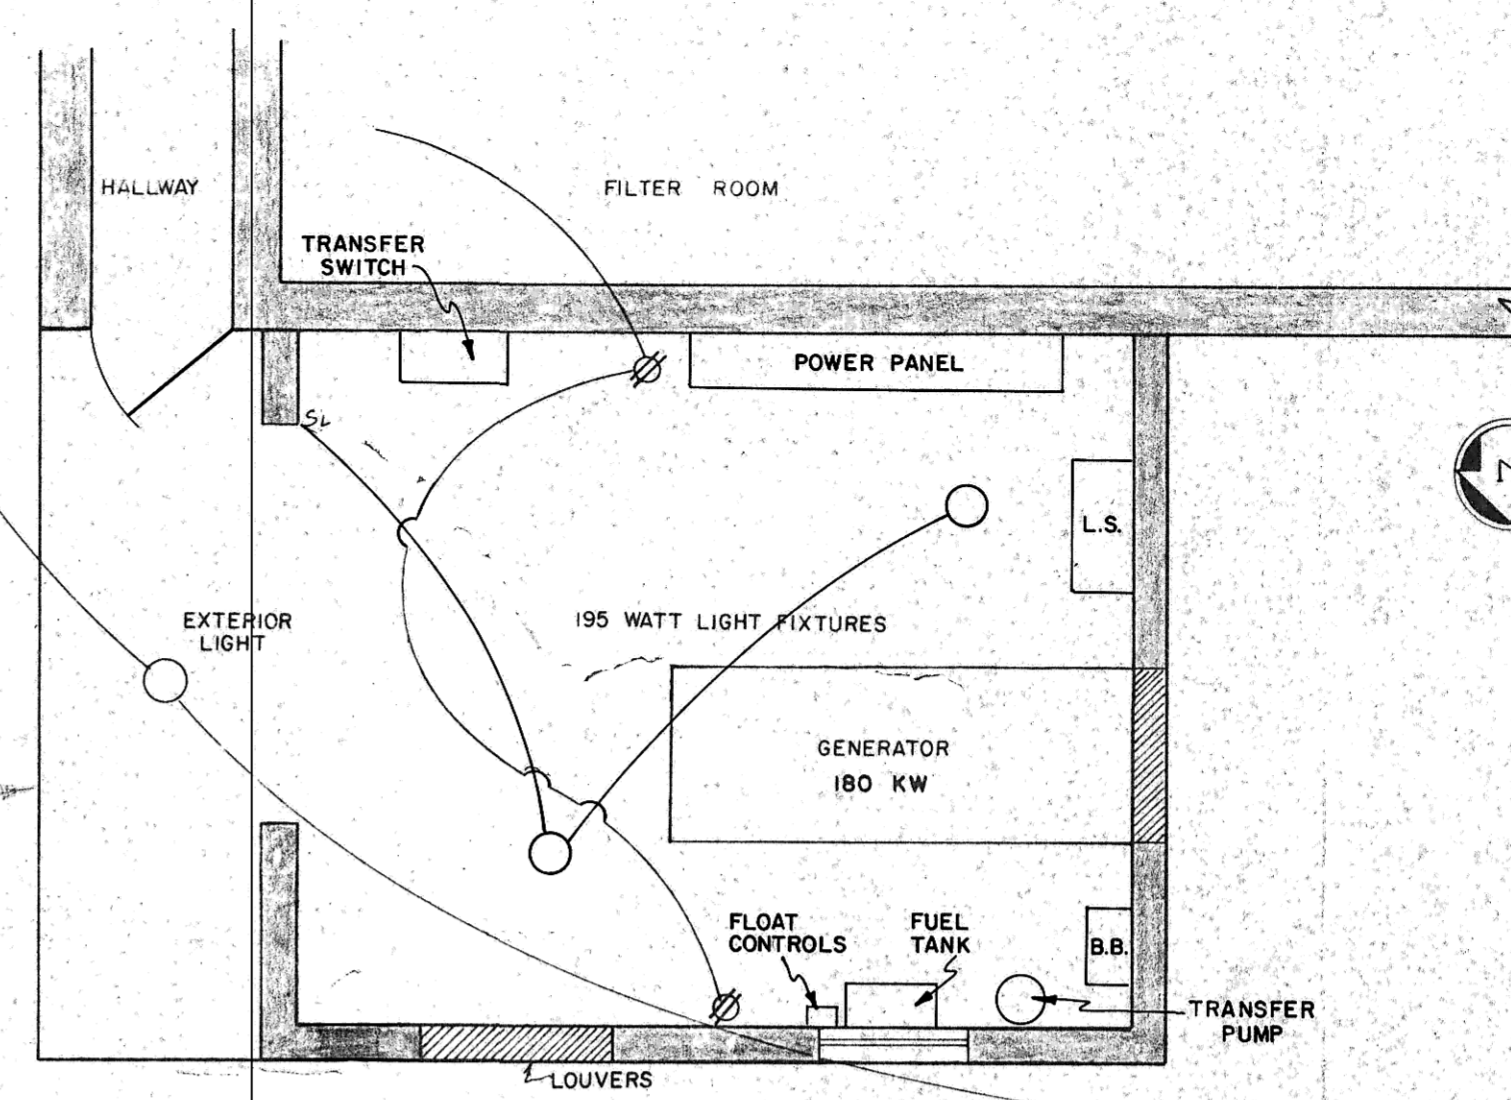


ELECTRICAL LAYOUT


SCALE: 1/4" = 1' 0"

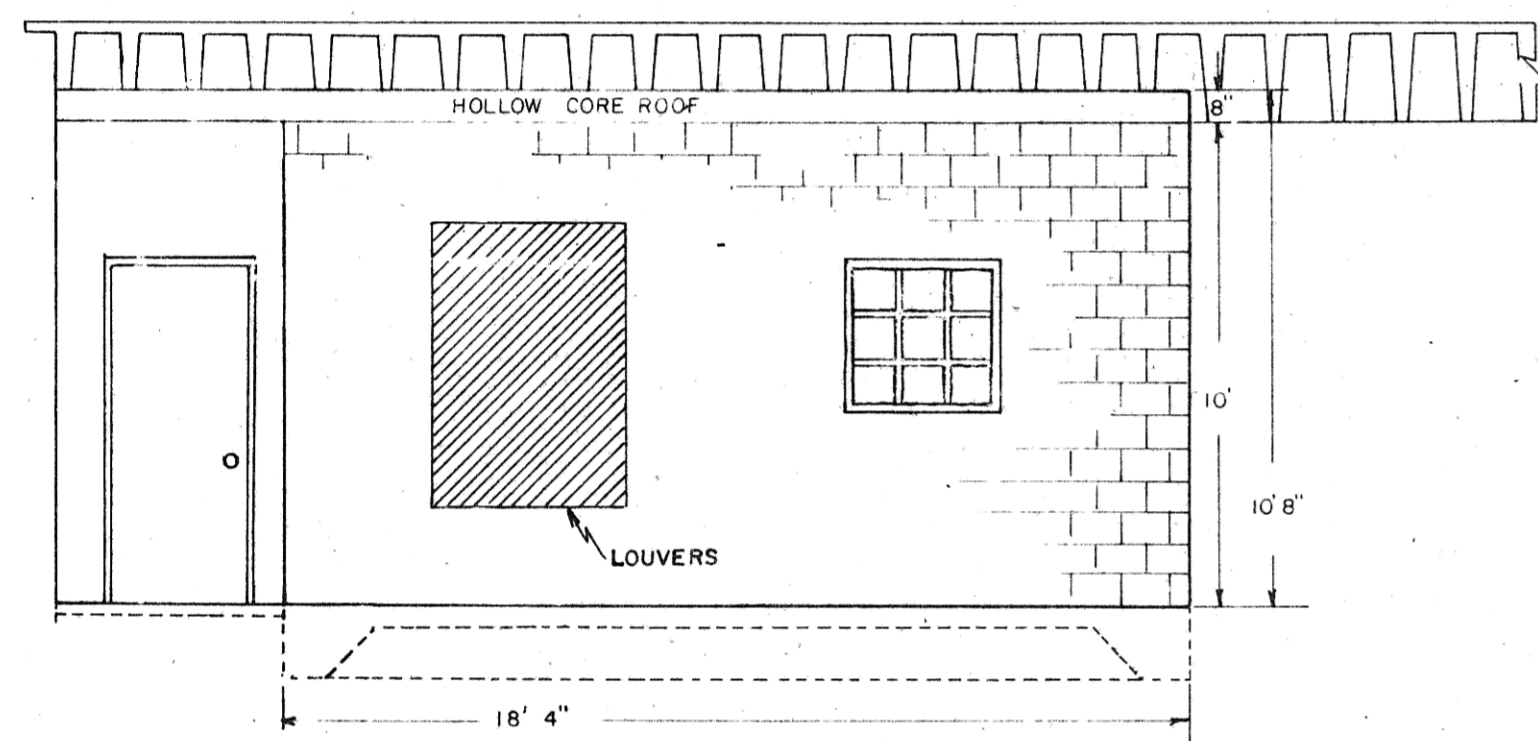


NORTH ELEVATION
SCALE: 1/4" = 1' 0"

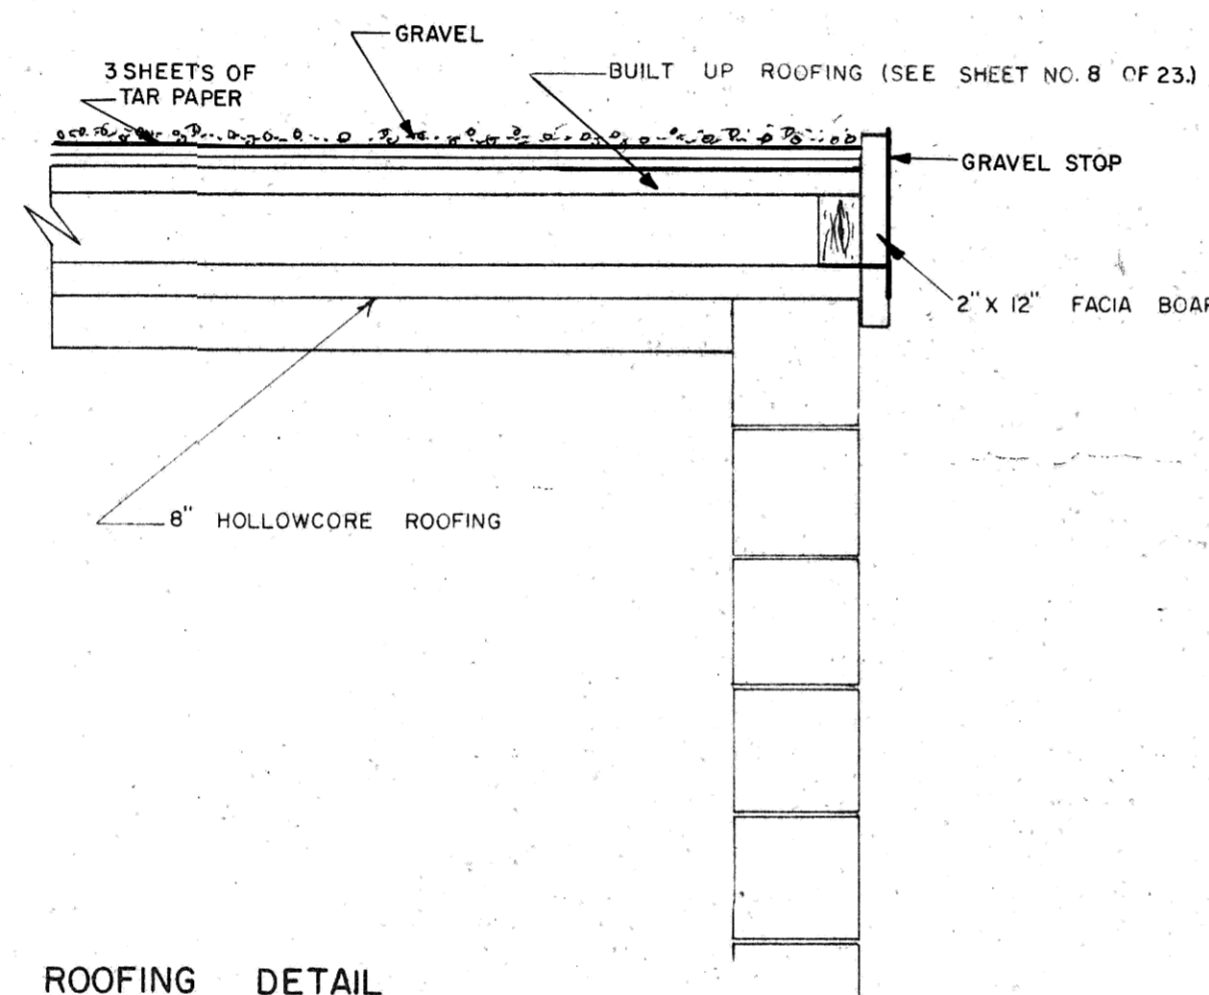


ROOFING DETAIL
SCALE: 1" = 1' 0"

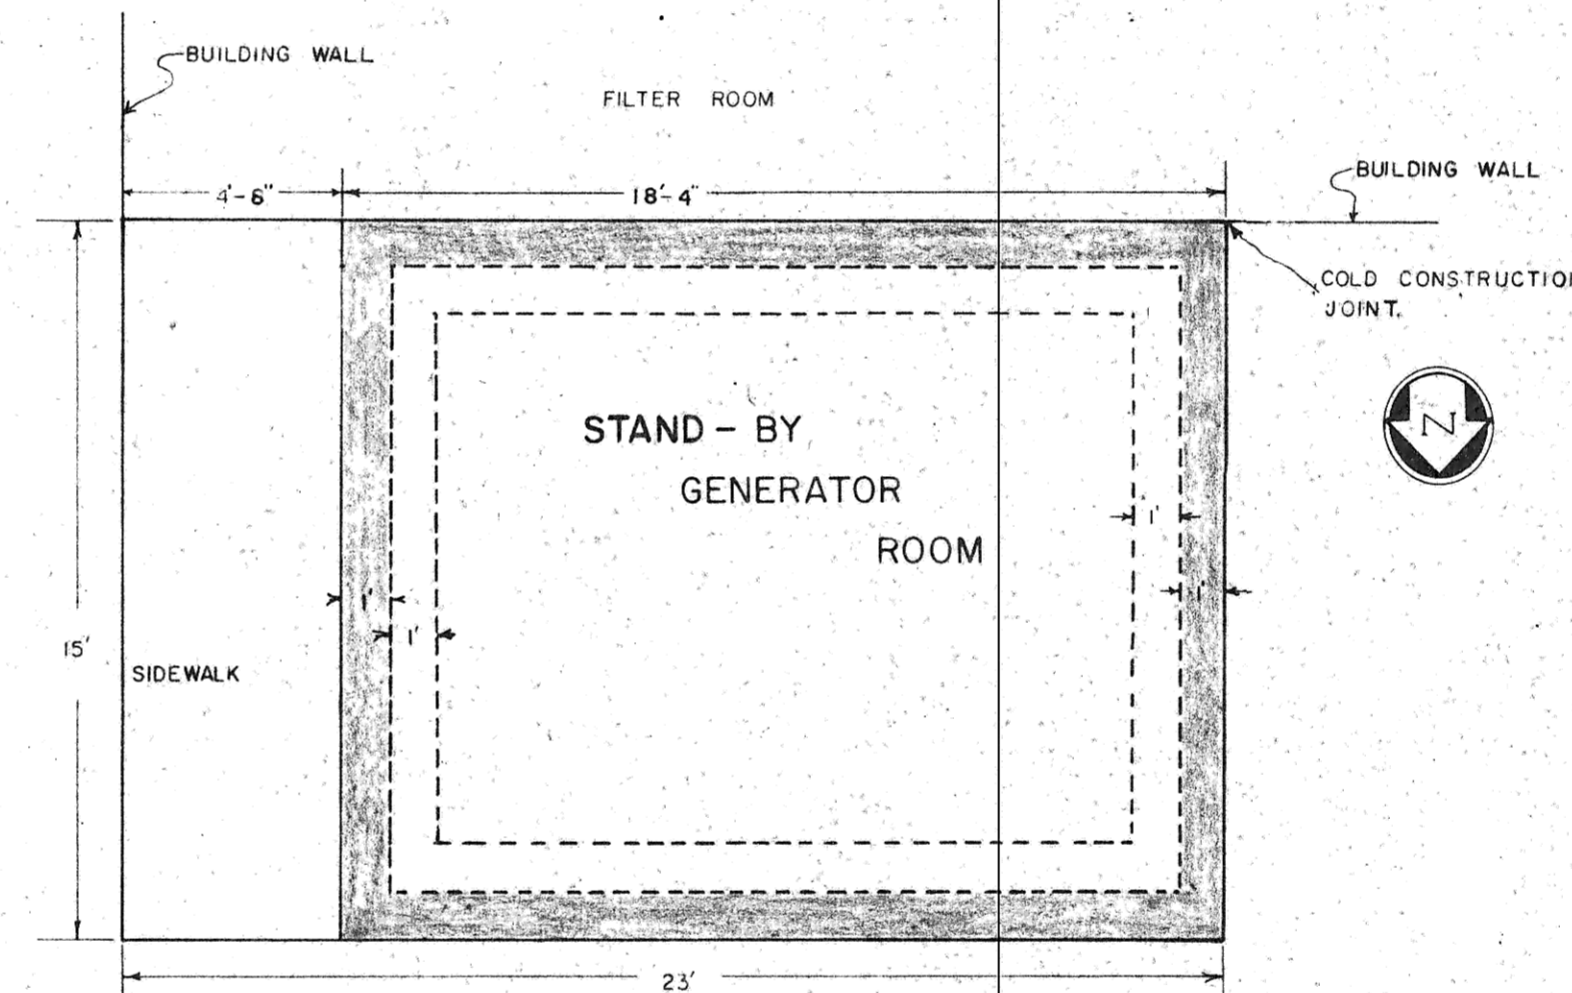

FOOTING PLAN
SCALE: 1/4" = 1' 0"

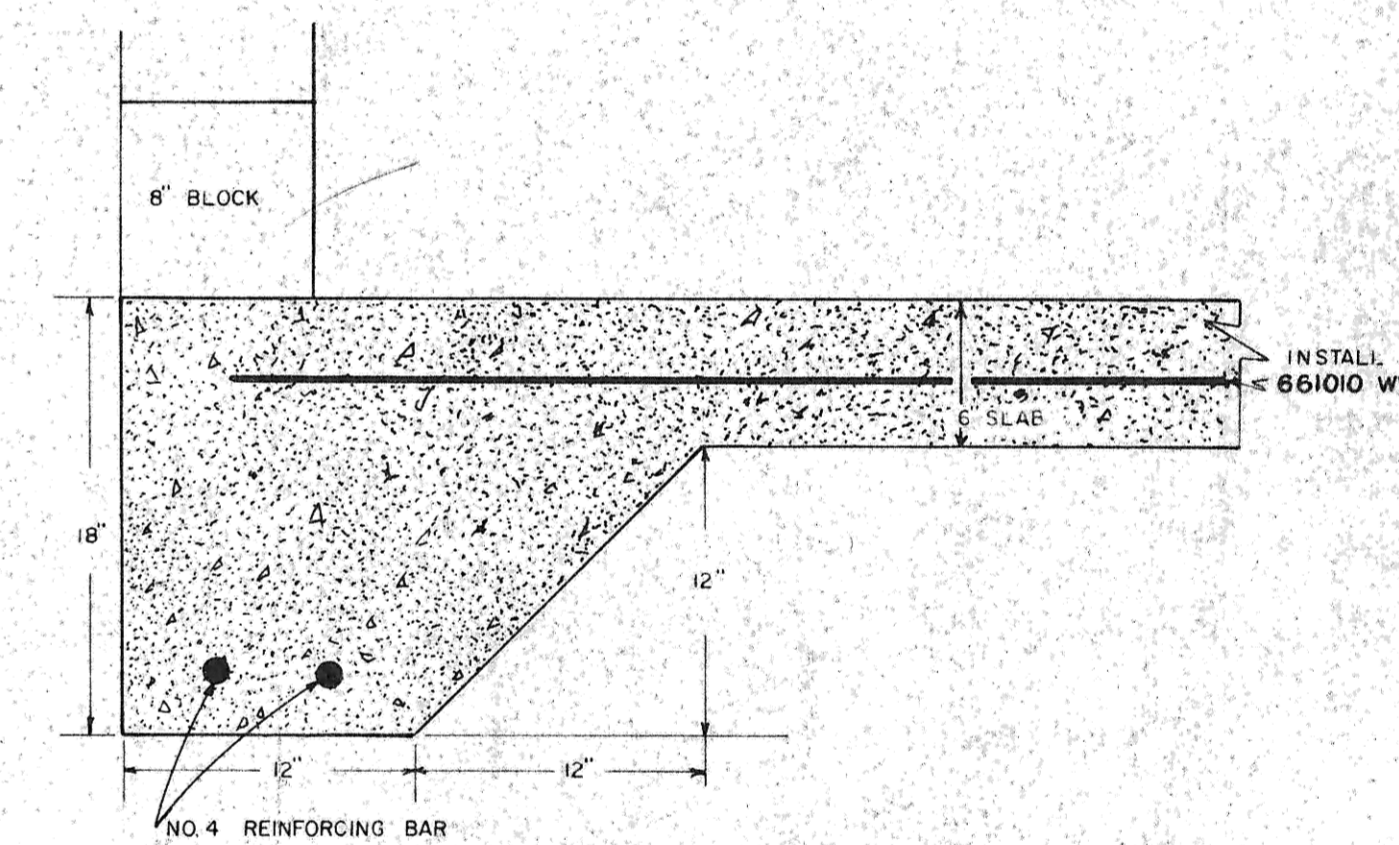


FOOTING DETAIL
SCALE: 1 1/2" = 1' 0"

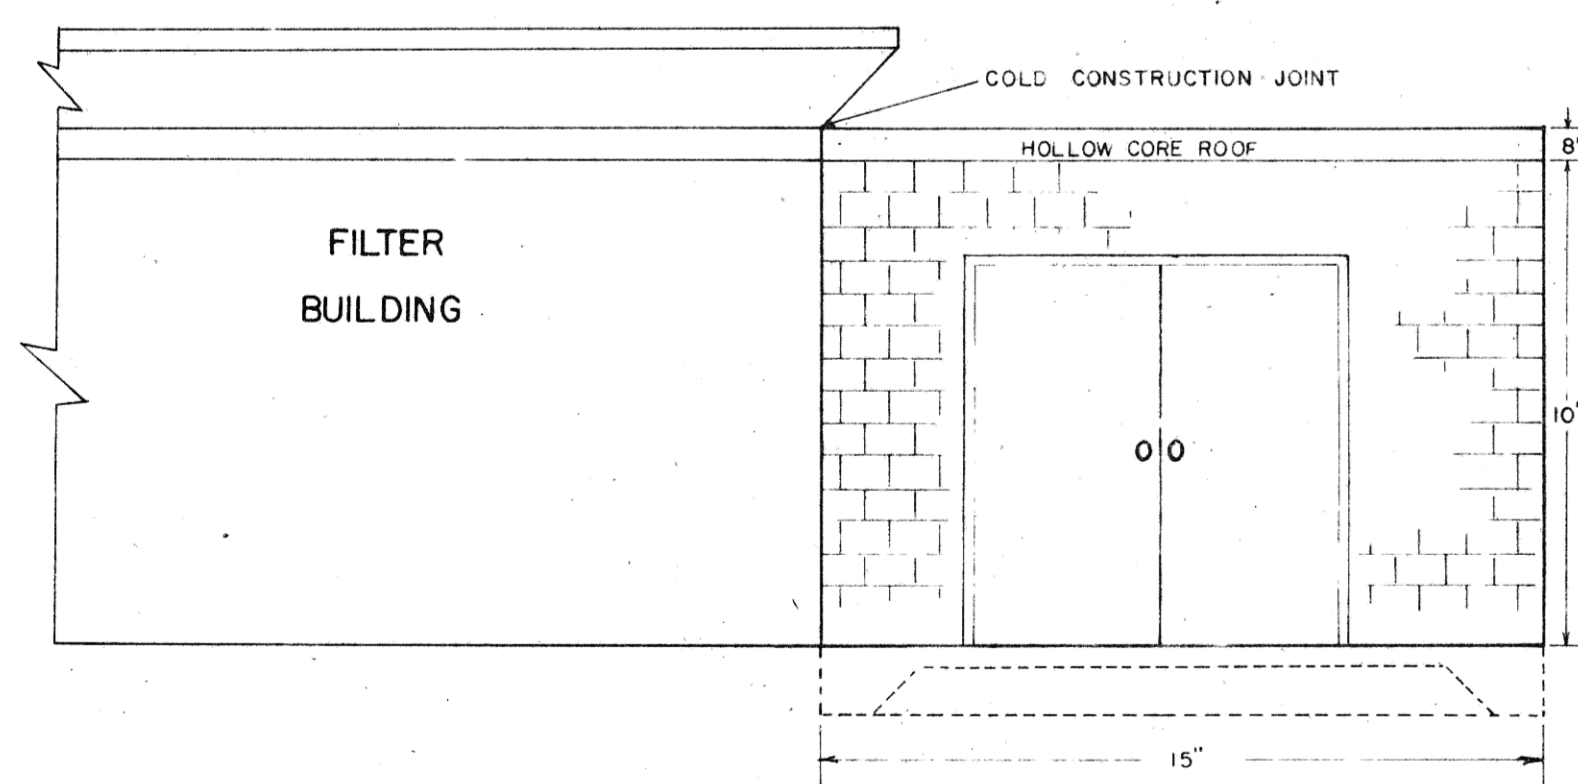

EAST ELEVATION
SCALE: 1/4" = 1' 0"

NOTE: ALL HOIST BEAMS LOCATED IN CHLORINE ROOM, FILTER ROOM AND GENERATOR ROOM SHALL BE INCLUDED IN LUMP SUM BID PRICE FOR ITEMS 1 AND 2 OF SCHEDULE-A.

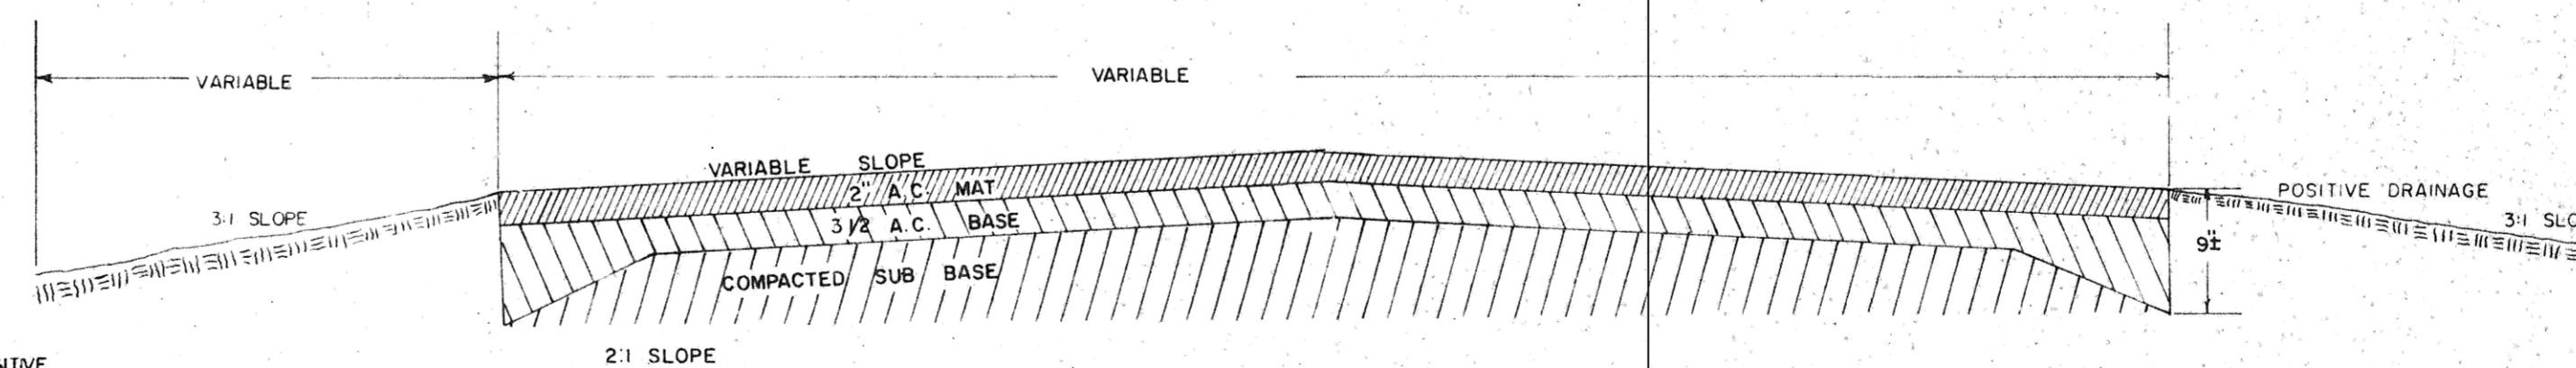

TYPICAL ROAD SECTION

NOTE: DRAINAGE SHOULD BE POSITIVE AND AWAY FROM BUILDING ON ALL SIDES.

REVISED APRIL 1977

JOB: UPGRADING WASTEWATER TREATMENT FACILITIES INCREMENT NO. 1 E.P.A. NO. C 380325-03 CONTRACTOR'S RECORD DRAWINGS (AS BUILT)	
FILE NO.	DATE: SEPTEMBER 1976
SHEET NO. 9 OF 23 SHEETS	
DRAWN BY: J3 JFP	CHECKED BY:
GENERATOR BUILDING 180 KW GENERATOR	
Toman Engineering Company Civil & Environmental Consultants P. O. Box 708 P. O. Box 852 Mandan, ND Boissevain, Man RKO OEO	